


**LEASED**

Private Disaster Recovery Hot Site/Business Continuity Work Site

 
Available Features:

- \* 100% Back-Up Power
- \* Dedicated Fiber Connectivity
- \* Circuit Monitoring
- \* Furnished or Unfurnished
- \* Access Controls
- \* Cameras
- \* Turnkey Design and Construction Services
- \* Private or Shared Conference Rooms
- \* 24/7/365 Network Operations Center & On-Site Security Officers
- \* Access to Tier IV Data Center
- \* Shipping and Receiving
- \* Concierge Services & more
- \* Award Winning Design & Superior Customer Service
- \* [www.fibertown.com](http://www.fibertown.com) 979.393.9100 [sales@fibertown.com](mailto:sales@fibertown.com)

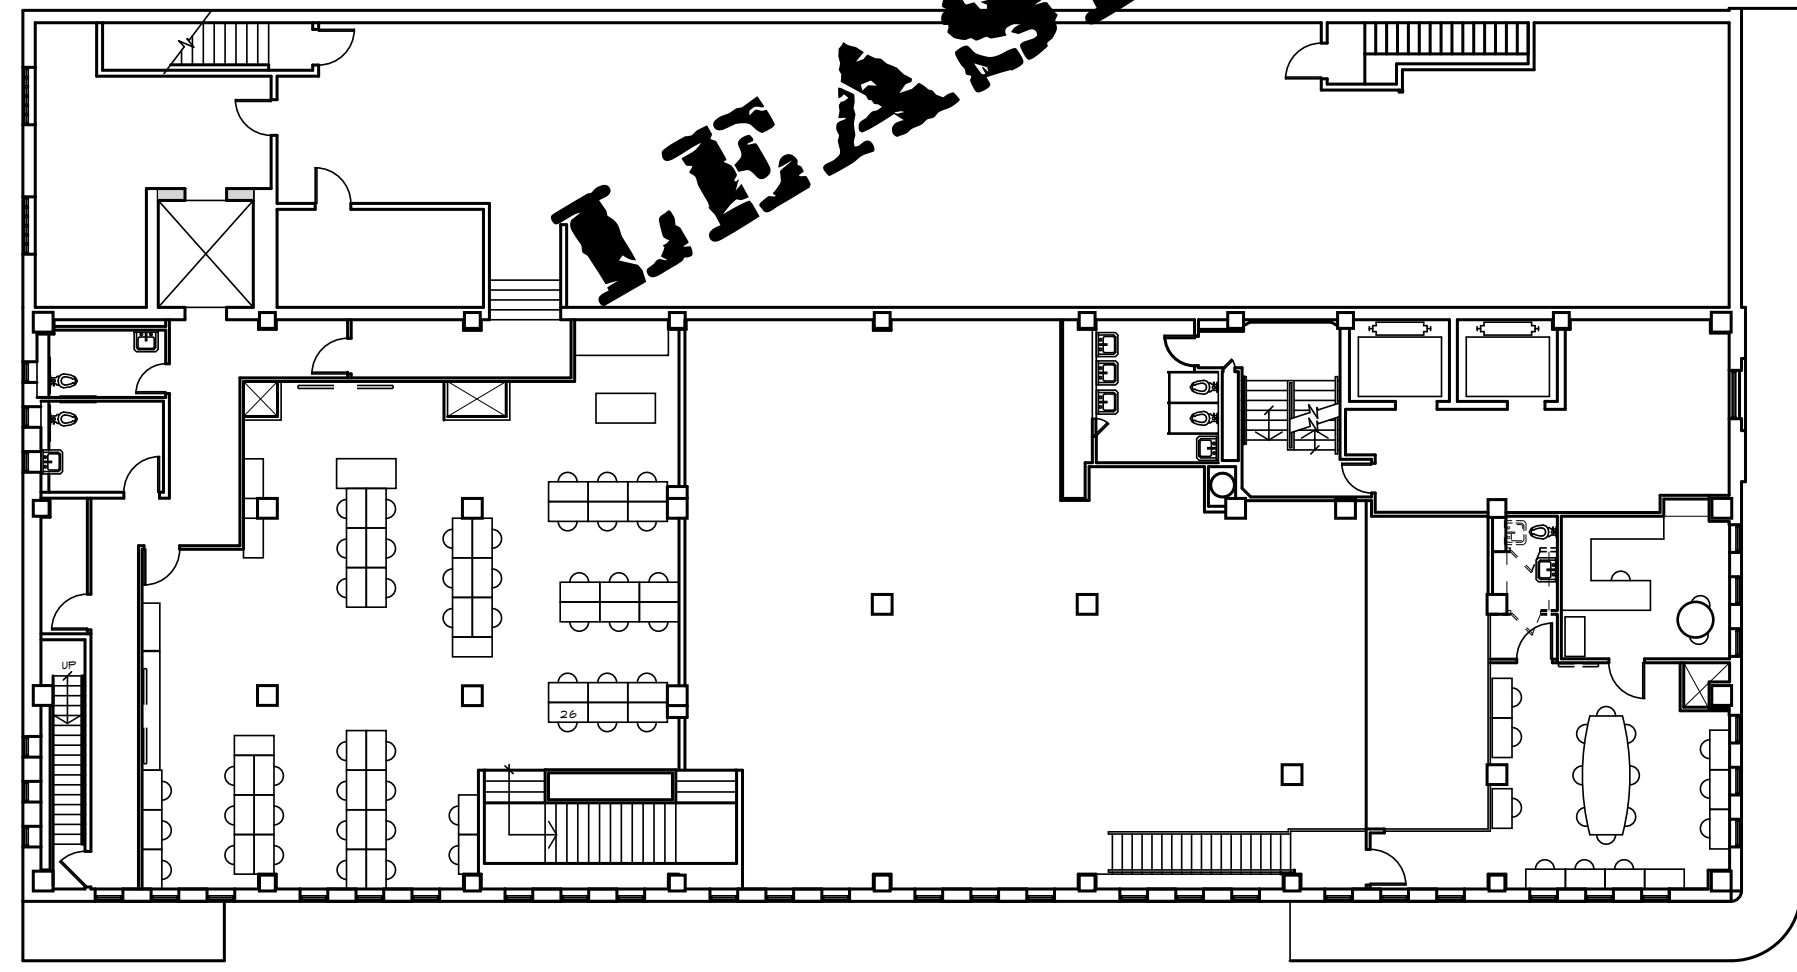

VARISCO BUILDING  
 DR SPACE

DOCUMENT IS NOT COMPLETE.  
 NOT INTENDED FOR  
 REGULATORY APPROVAL,  
 PERMIT, OR CONSTRUCTION  
 23 FEBRUARY 2010



**1** Mezzanine Floor Plan  
 Scale: 1/8"=1'-0"

